
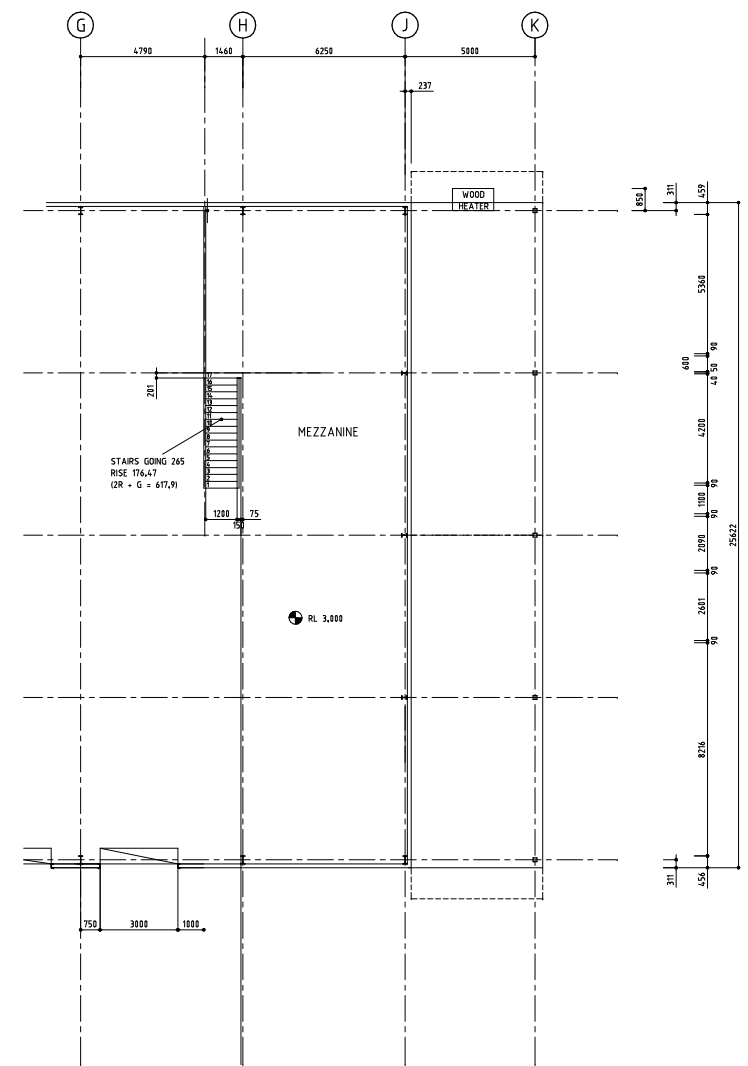


SECTION A-A
SCALE 1:100

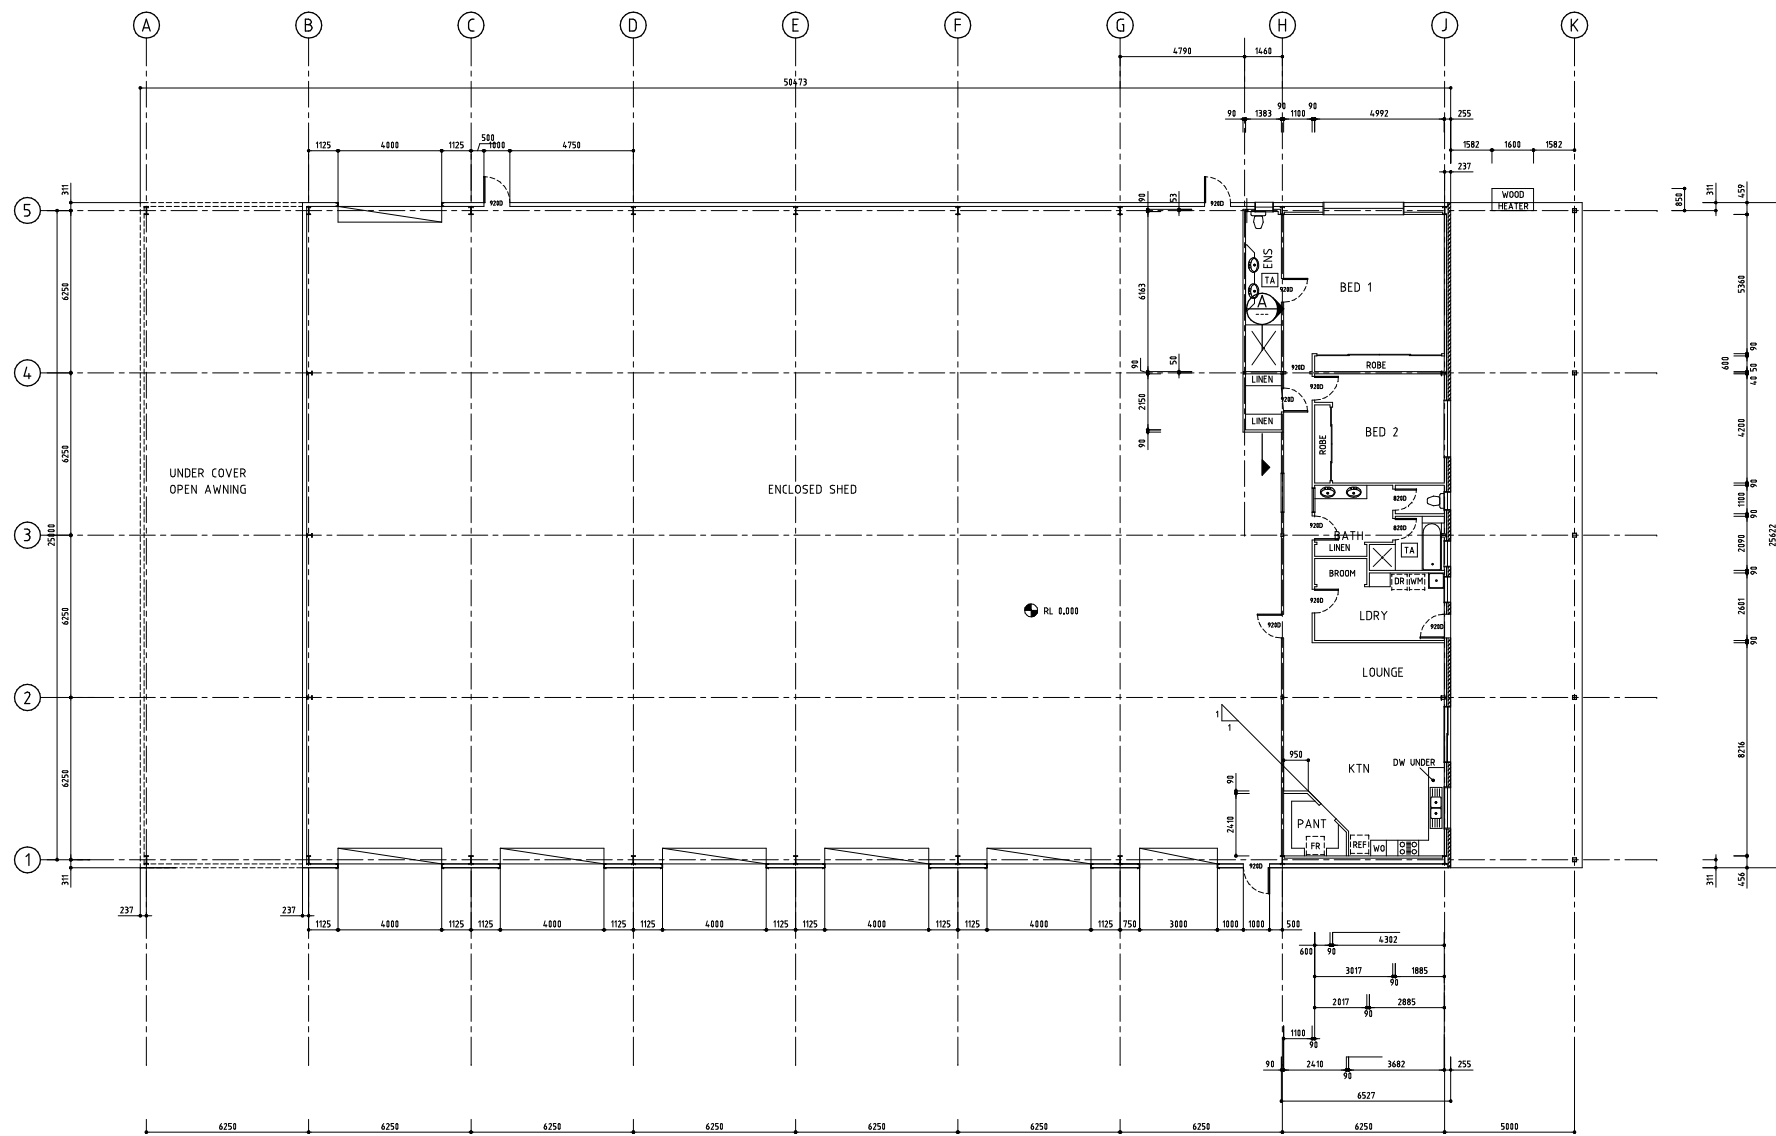

NOTES:

- THIS DRAWING IS TO BE READ IN CONJUNCTION WITH THE SPECIFICATION
- THE BUILDER SHALL COMPLY WITH THE BUILDING CODE OF AUSTRALIA
- THE BUILDER SHALL AT ALL STAGES PROVIDE A SAFE WORKING ENVIRONMENT
- THE BUILDER SHALL CHECK ALL DIMENSIONS BEFORE COMMENCING ANY WORKS
- THE BUILDER SHALL GIVE ALL NOTICES
- THE BUILDER SHALL PROVIDE THE NECESSARY FIXINGS WHETHER OR NOT DETAILED ON THE DRAWINGS OR MENTIONED IN THE SPECIFICATIONS
- ELECTRICITY IS TO BE INSTALLED BY A QUALIFIED ELECTRICIAN TO LOCAL ELECTRICITY AUTHORITY STANDARDS
- ALL WINDOWS TO BE ALUMINUM FRAMED

- SKY LIGHT (TUBE STYLE Ø300)
- DP - DOWN PIPE
- SD - SMOKE DETECTOR
- TA - TASTIC

THIS DRAWING IS THE PRIVATE PROPERTY OF GARTALE PTY LIMITED AND WITHOUT THEIR CONSENT MUST UNDER NO CIRCUMSTANCES BE SHOWN OR GIVEN TO ANY COMPETITORS OR THIRD PARTIES. ALL LEGAL RIGHTS RESERVED.

A		GEN REV		DATE	
REVISION		DETAILS OF REVISION		DATE	
1:100		1 2 3 4 5 6 7 8 9 10 M			

THIS DRAWING WAS PREPARED BY
GARTALE PTY LIMITED
ABN 60 057 900 486
PO BOX 185, 119 CULCHES ST, CLIVE NSW 2270.
PH (066) 4708 4000

PROPOSED SHED LOT 1 DP 1322881, DUMARESQ RD, ARMIDALE FLOOR PLAN		DRAWING NUMBER		REVISION	
DRN: 8 LLOYD	DK: +	A0-2573 / 01		A	
DATE: JUNE 26	DATE: +				